


REVISION SCHEDULE				
REV. NO.	REV. DESCRIPTION	REV. DATE	DRAWN	CHECKED
PL1	ISSUED FOR IRISH WATER PIRE CONNECTION	31/07/2019	JPC	JFC
A	ISSUED FOR PRE-PLANNING MEETING	30/09/2019	JPC	JFC
PL2	ISSUED FOR PLANNING	04/11/2019	JPC	JFC
PL3	IRISH WATER COMMENTS INCORPORATED	17/12/2019	JPC	JFC
PL4	ISSUED FOR PLANNING	17/02/2020	JPC	JFC

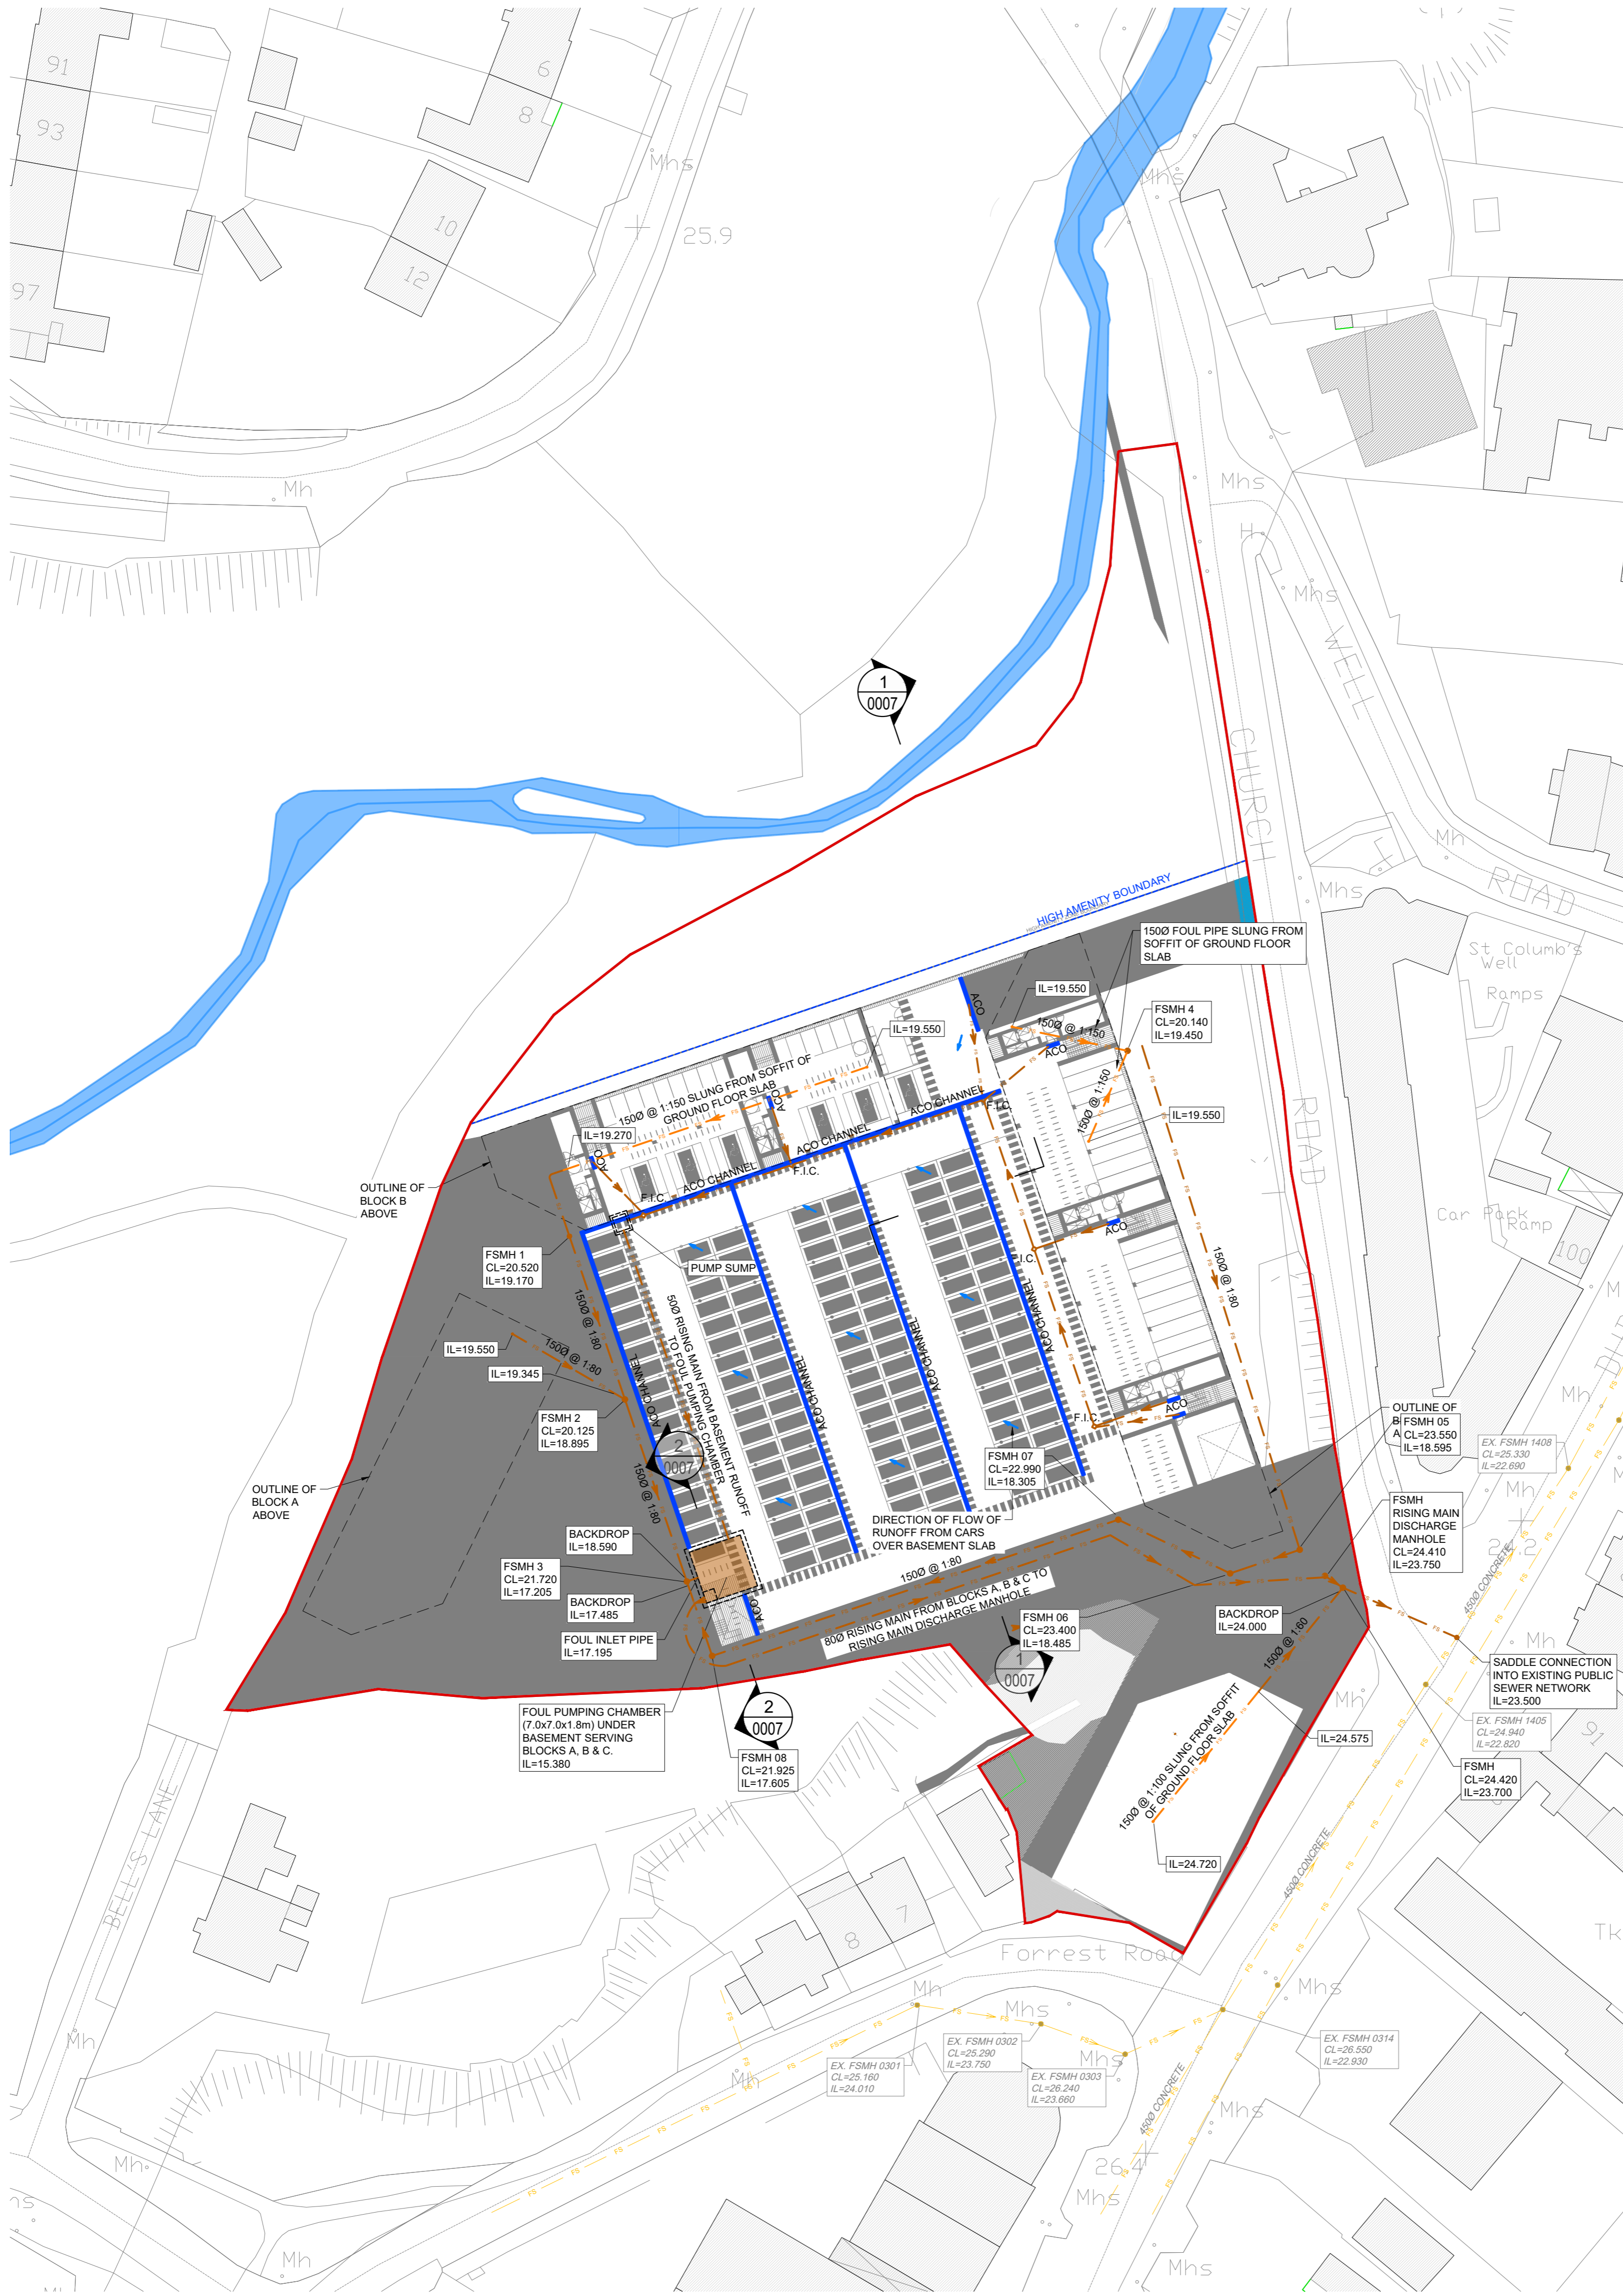

DRAINAGE LEGEND	
	FOUL SEWER (EXISTING)
	FOUL SEWER (NEW)
	FOUL SEWER (SLUNG FROM GROUND FLOOR SLAB)
	SURFACE WATER SEWER (EXISTING)
	SURFACE WATER SEWER (NEW)
	FOUL SEWER RISING MAIN
	SURFACE WATER RISING MAIN
	EXISTING WATER MAIN
	PROPOSED WATER MAIN
	MH (NEW FOUL)
	MH (NEW SURFACE)
	NEW FIRE HYDRANT
	NEW SLUCE VALVE
	NEW AIR VALVE
	NEW SCOUR VALVE
	NEW WASHOUT HYDRANT
	NEW METER
	NEW BULK METER
	RAIN WATER DOWN PIPE
	POP UP
	SOIL VENT PIPE
	FMH (FOUL - EXISTING)
	SMH (SURFACE - EXISTING)
	MH (DEMOLISHED - EXISTING)
	I.C. (FOUL)
	I.C. (SURFACE)
	I.C. (EXISTING)
	FLOOR GULLY
	BACK INLET GULLY TRAP
	ACO DRAINAGE CHANNEL
	SURFACE WATER EXCEEDANCE FLOW ROUTE
	STREAM OVERFLOW ROUTE
	BURST WATER MAIN FLOW ROUTE

- NOTES:**
- ALL FOUL PIPES ARE UPVC IN ACCORDANCE WITH SECTION 3.13 OF IRISH WATER WASTEWATER CODE OF PRACTICE U.N.O.
 - ALL SURFACE WATER PIPES ARE HDPE U.N.O.
 - ALL WATERMAIN PIPES ARE HDPE IN ACCORDANCE WITH SECTION 3.9 OF IRISH WATER CODE OF PRACTICE U.N.O.
 - ALL FOUL RISING MAIN PIPES ARE HDPE IN ACCORDANCE WITH SECTION 3.14 OF THE IRISH WATER WASTEWATER CODE OF PRACTICE.
 - ACO CHANNELS PROVIDED AT EACH DOOR THRESHOLD IN BASEMENT
 - ALL DISTRIBUTOR PIPES CONTAIN 1500 HDPE PERFORATED PIPE U.N.O. SEE DRAWINGS S-0011 - S-0014 FOR DETAILS.
 - ALL MANHOLES IN LANDSCAPED AREAS TO HAVE CONCRETE SURROUND. SEE DRAWINGS S-0011 - S-0014 FOR DETAILS.

Drawing Stage: PLANNING	Project Details:	Drawn by:	Checked by:	Approved by:	Date:	 Behan House, 10 Lower Mount Street, Dublin 2, D02 HT71 Tel: +353 (0)1 661 1100 e-mail: info@cora.ie Web: www.cora.ie						
	Site Address:	JPC	KOM	JFC	26/07/2019							
	Client:	Project Name:	Scale:	Project Number:	1867							
	Architect:	THE LORD MAYOR REDEVELOPMENT	1:500 @ A1	1867	Originator:							
	M&E Designer:	DUBLIN ROAD, SWORDS, Co. DUBLIN	SA	CORA	Zone:							
Contractor:	JACKO INVESTMENTS	Drawing Title:		Project:	Originator:	Zone:	Level:	Type:	Discipline:	Drawing No:	Stage:	Revision:
	AUGHEY O'FLAHERTY ARCHITECTS	BASEMENT DRAINAGE PLAN		SA	CORA	00	B1	DR	C	0003	04	PL4