

THIS DRAWING IS COPYRIGHT © ALL RIGHTS RESERVED. NO PART OF THIS DRAWING MAY BE REPRODUCED, STORED IN A RETRIEVAL SYSTEM OR TRANSMITTED IN ANY FORM OR BY ANY MEANS WITHOUT THE PRIOR WRITTEN PERMISSION FROM MCELLIGOTT CONSULTING ENGINEERS LIMITED.

NOTES

01. DO NOT SCALE. USE FIGURED DIMENSIONS ONLY.
02. THIS DRAWING IS TO BE READ IN CONJUNCTION WITH ALL OTHER RELEVANT ARCHITECTURAL AND ENGINEERING DRAWINGS.
03. FINAL LOCATION OF MINIPILLARS & DUCTS ETC TO BE AGREED WITH ESB SUPERVISOR PRIOR TO INSTALLATION, AND IN COMPLIANCE WITH ESB DESIGN DRAWING FOR THIS PROJECT.
04. PROVIDE FOR ESB METER CABINET, INTERNAL METER & BRACKETS, SURGE PROTECTION & CABLE TO PUMPING STATION CONTROL PANEL.
05. REFER TO ESB PUBLICATION ELECTRICAL SERVICES GUIDE BOOK FOR HOUSING SCHEMES FOR ALL INSTALLATION DETAILS.
06. THIS DRAWING SHOULD BE READ IN CONJUNCTION WITH THE NATIONAL CODE OF PRACTICE FOR CUSTOMER INTERFACE ISSUED BY ESB.
07. ALL ELECTRICAL WORKS SHALL BE CARRIED OUT IN ACCORDANCE WITH THE ET101 REGULATIONS
08. THIS PROPOSAL IS FOR INFORMATION ONLY AND IS SUBJECT TO APPROVAL FROM THE ESB REPRESENTATIVE AND PLANNING PERMISSION AND SHOULD BE READ IN CONJUNCTION WITH ESB FINAL DESIGN DRAWING.

LEGEND

B	FOR INFORMATION	RT	TMC	TMC	01/11/2019
A	FOR INFORMATION	RT	TMC	TMC	31/10/2019
ISSUE	DESCRIPTION	DRN	ORIG	APP	DATE



McElligott
CONSULTING ENGINEERS
 H2a Centrepoint Business Park, Oak Road, Dublin 12
 Tel: +353 (0)1 424 3014 email: info@mcelligott.ie web: www.mcelligott.ie

CLIENT
JACKO INVESTMENTS REDEVELOPMENT

PROJECT
THE LORD MAYORS, MAIN STREET SWORDS

TITLE
ESB SITE SERVICES

SHEET	SCALE	PROJECT No.	DRAWING No.
A3	1:500	19040	E001

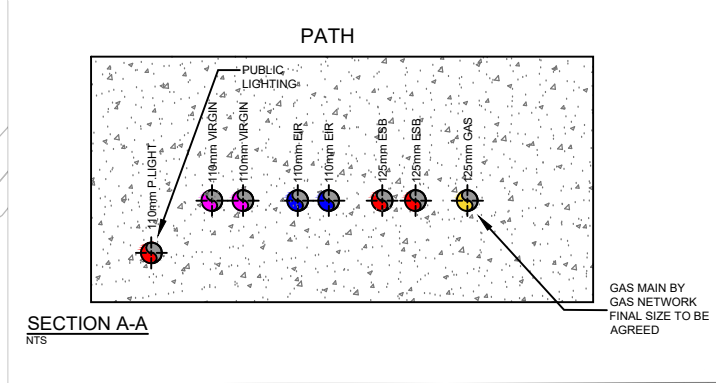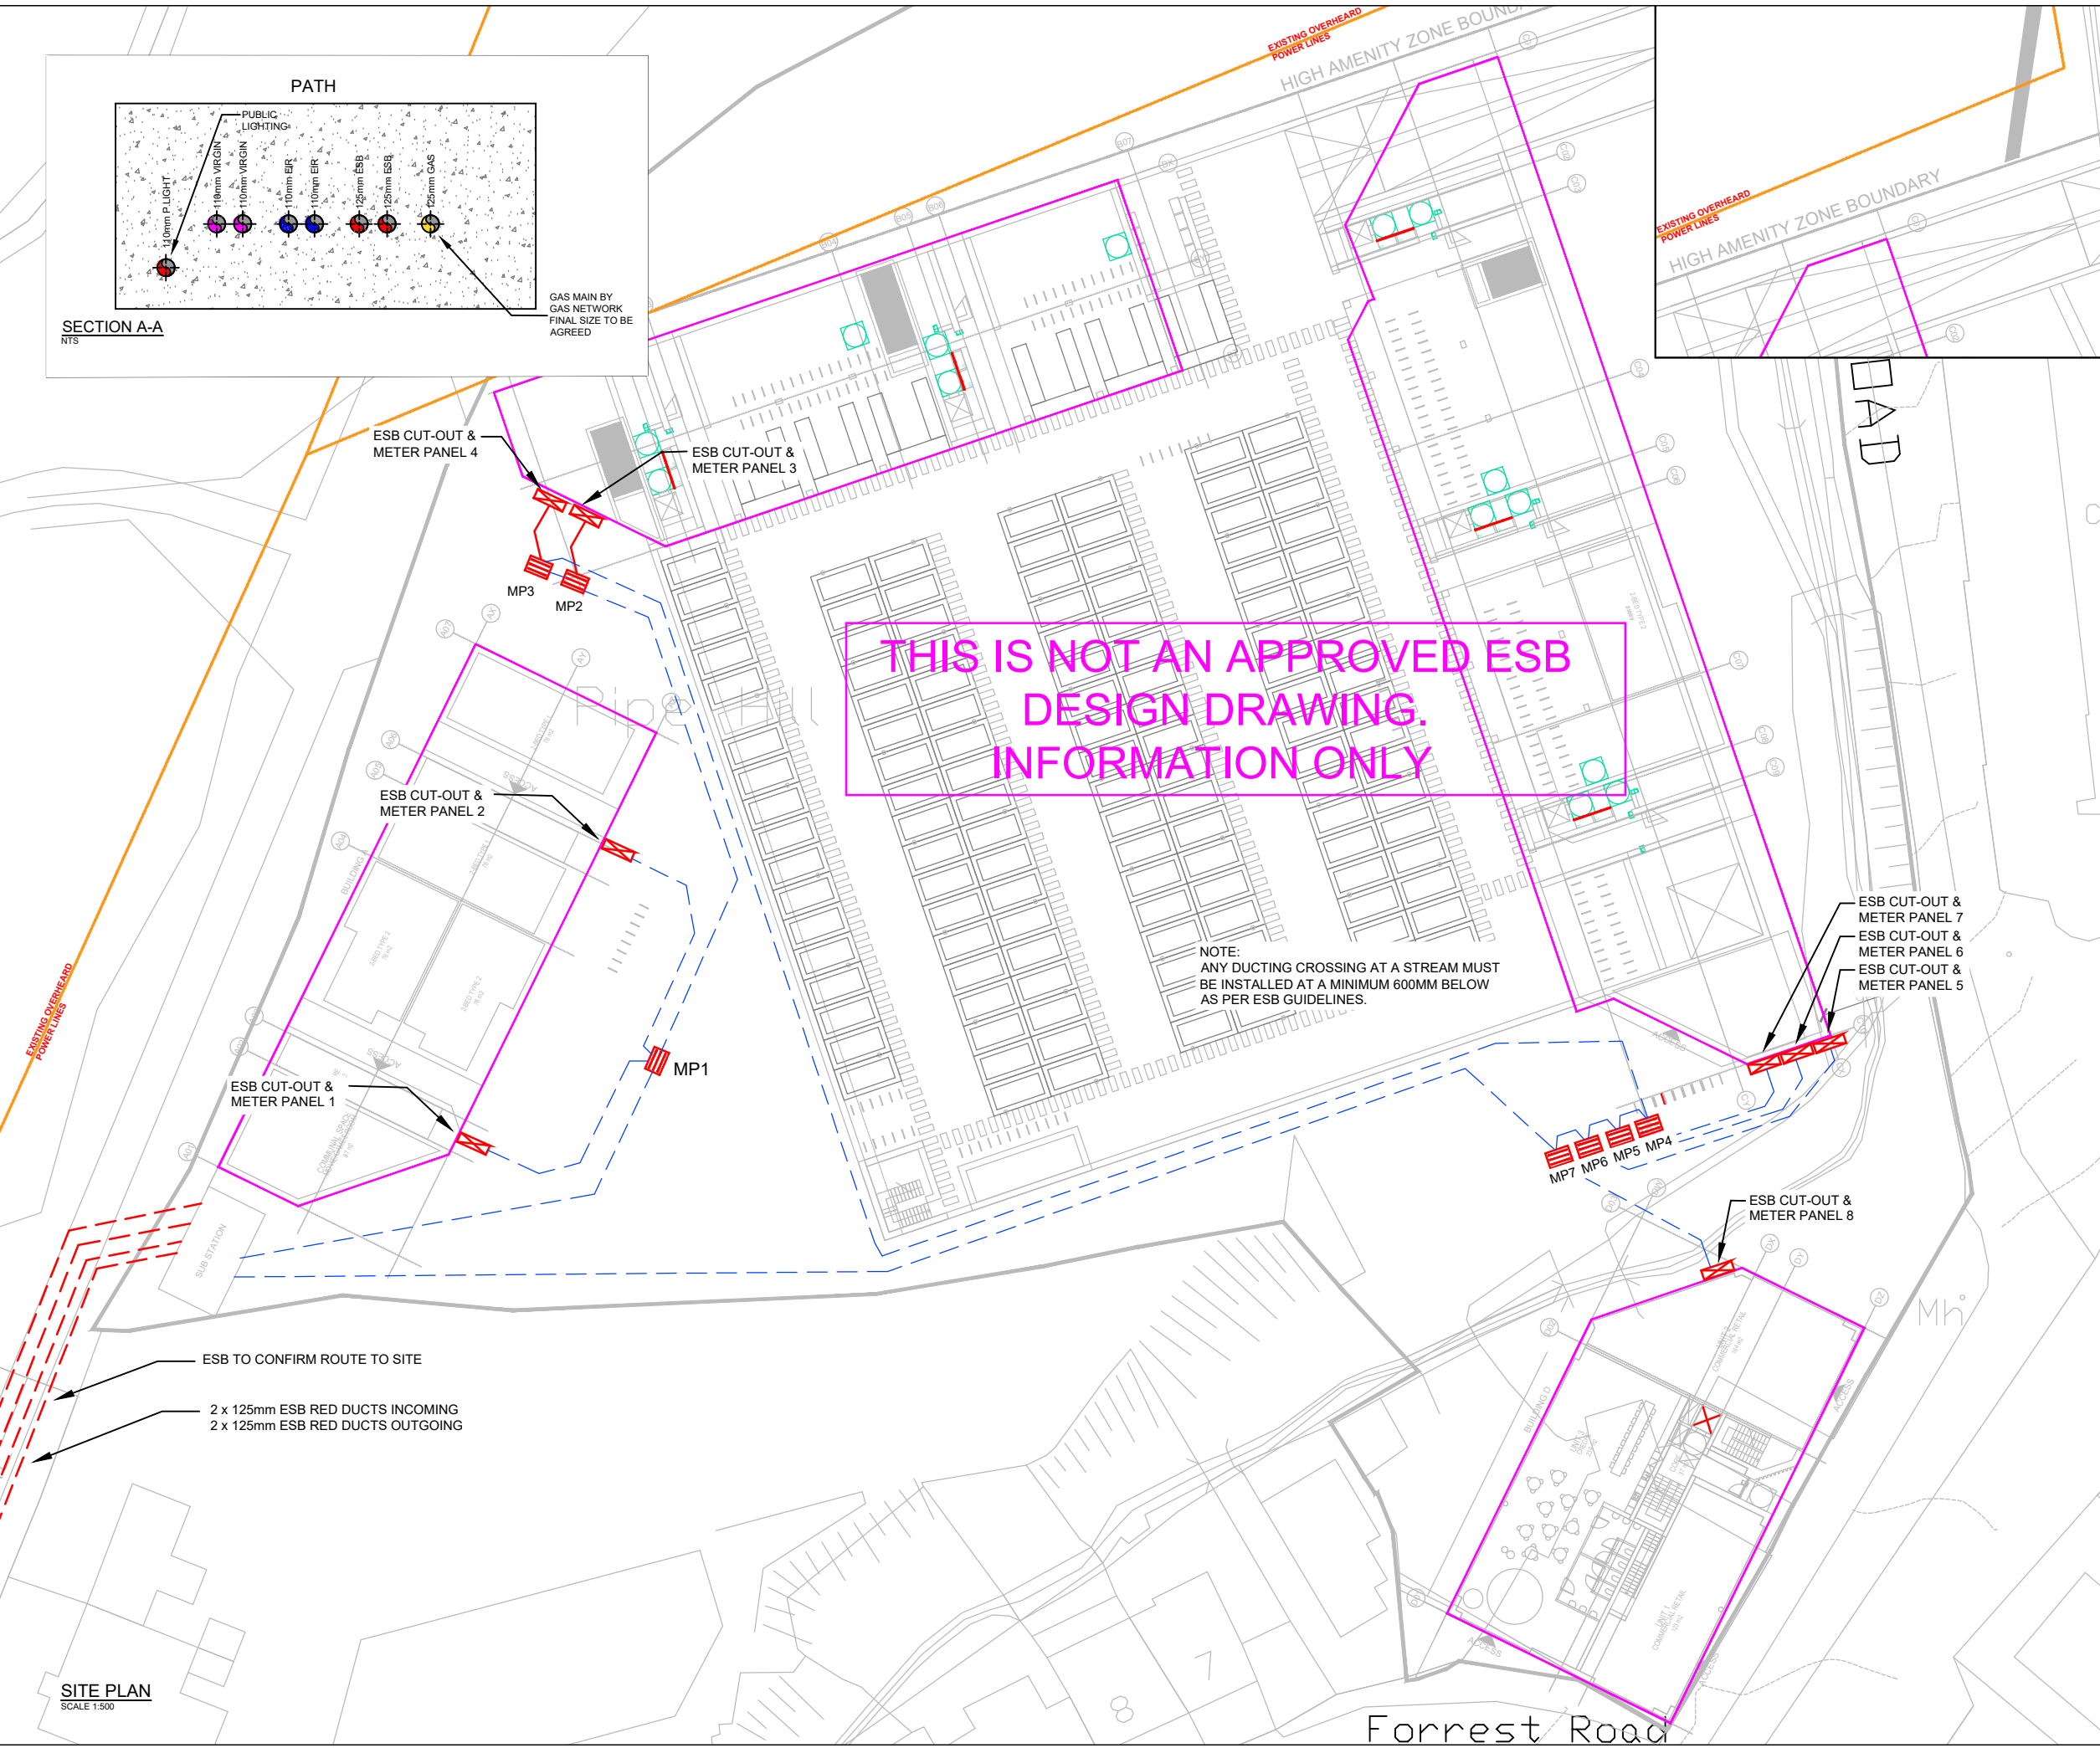

SITE PLAN
 SCALE 1:500

Forrest Road